

EXHIBIT "C"  
SHOPPING CENTER SITE PLAN


**BOHLER ENGINEERING, INC.**

- CML & CONSULTING ENGINEERS • PROJECT MANAGERS
- ENVIRONMENTAL & SITE PLANNERS • MUNICIPAL ENGINEERS

Main Office:  
786 MOUNTAIN BLVD.,  
WATCHUNG, N.J. 07060  
(908) 688-6300

Branch Office:  
29 MAIN STREET,  
MAINLAND, PA. 19451  
(215) 256-1100

NOTE: PHOTO 26 & 27 ARE OF  
MCDONALD'S & DUNKIN DONUTS  
IN ADJACENT SHOPPING CENTER  
TO THE EAST

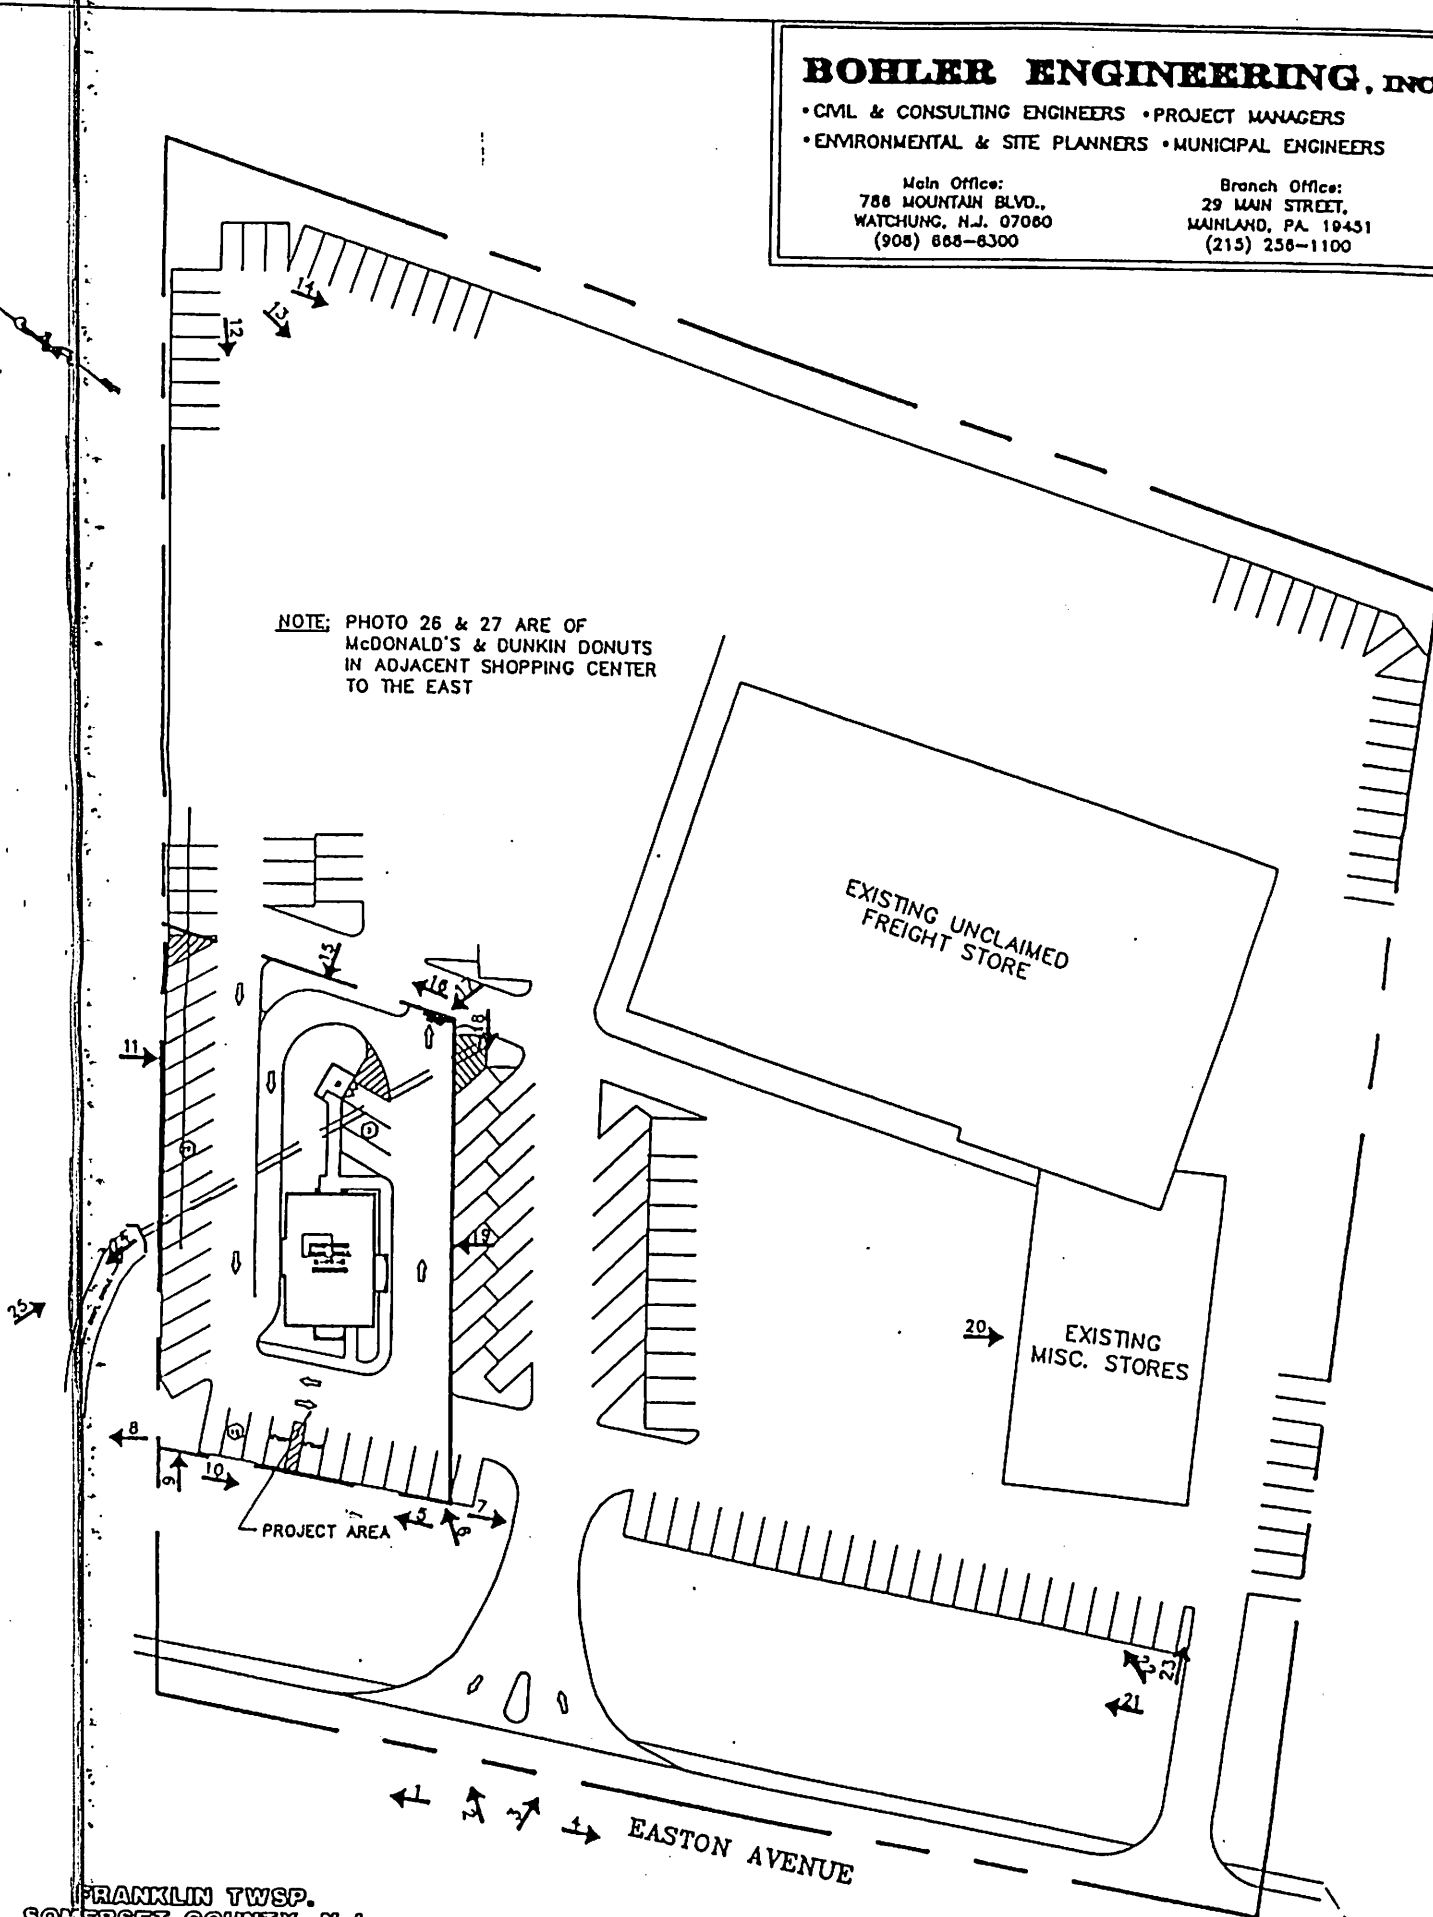

FRANKLIN TWSP.  
SOMERSET COUNTY, N.J.  
PHOTO LOCATION PLAN

SCALE: 1"=40'  
SEPT. 16, 1991



527

Easton Ave

Easton Ave

527

50 feet 10 m

© AND © 2010 NAVTEQ © 2011 Microsoft Corporation  
Pictometry, Bird's Eye © 2010 Pictometry International Co.